



LEGEND


- FAN
- FLUORESCENT LIGHT
- LIGHT
- DUPLEX OUTLET
- WEATHER PROOF DUPLEX OUTLET
- OUTLET LOCATED 48" ABOVE FIN. FLR.
- 330 OUTLET
- DIRECTIONAL RECESS LIGHT
- RECESS LIGHT
- RECESS LIGHT FOR WPT ARPA
- SINGLE TUBE FLOOR.
- FLOOD LIGHTS
- SWITCH
- SMOKE DETECTOR
- CHIMES
- EXHAUST FAN
- PHONE OUTLET
- CABLE OUTLET

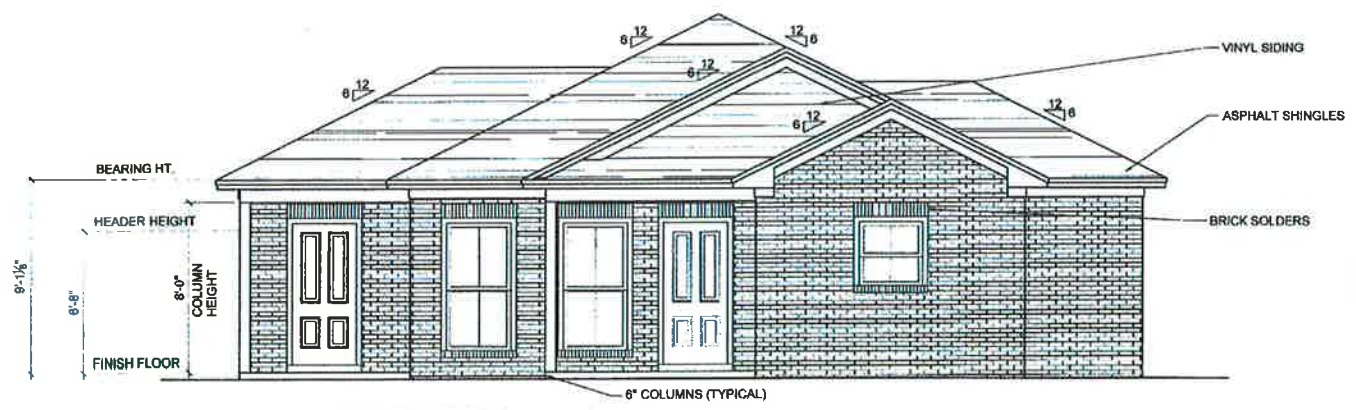


FRONT ELEVATION
SCALE: 1/4" = 1'-0"

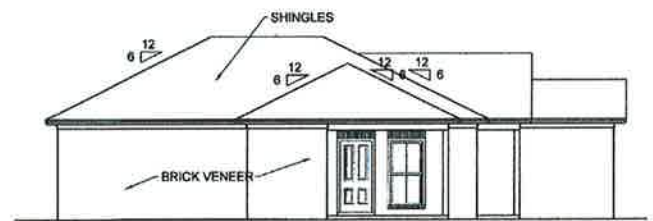


LEFT SIDE ELEVATION
SCALE: 1/8" = 1'-0"

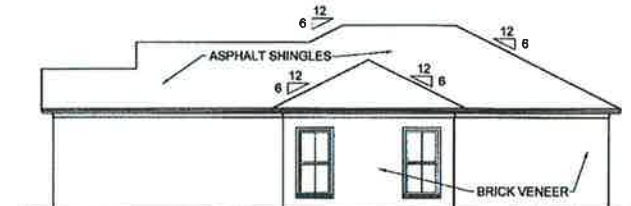


RIGHT SIDE ELEVATION
SCALE: 1/8" = 1'-0"

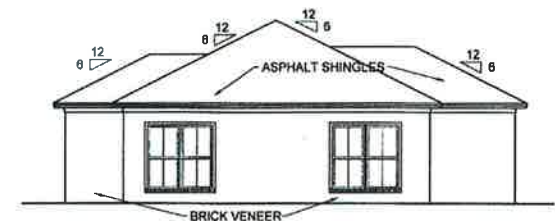

REAR ELEVATION
SCALE: 1/8" = 1'-0"

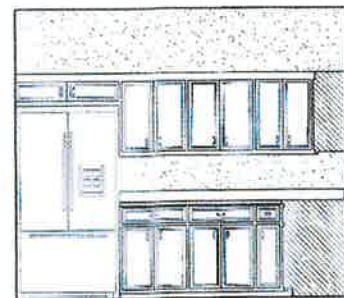


KITCHEN
SCALE: 3/8" = 1'-0"

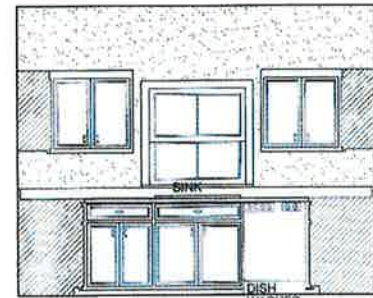


KITCHEN
SCALE: 3/8" = 1'-0"





KITCHEN
SCALE: 3/8" = 1'-0"

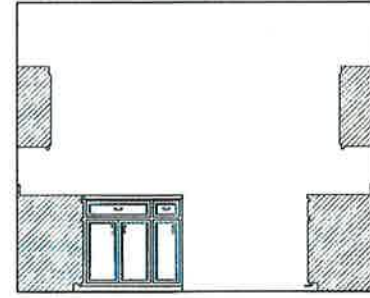

KITCHEN
SCALE: 3/8" = 1'-0"

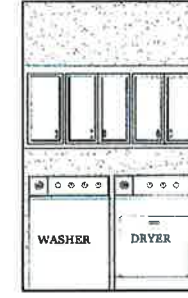

UTILITY
SCALE: 3/8" = 1'-0"

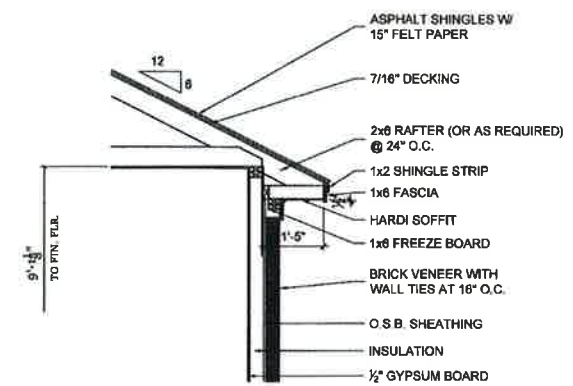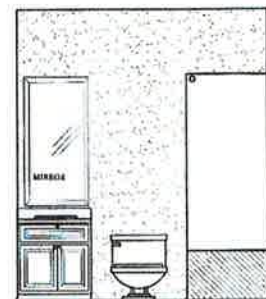

1 TYP WALL SECTION
SCALE: 1/2" = 1'-0"

Till Design Group
WILLIAM & DAVID TILL
5210 TILL ROAD
MILLBROOK, ALABAMA
(334) 799-5264

A RESIDENCE
BY:
ALL ABOUT
CONSTRUCTION

CONSTRUCTION DOCUMENTS

Project Number: 20-078
Date: 10/30/2020
Revisions:

Sheet Description
EXTERIOR ELEVATIONS
INTERIOR ELEVATIONS
ELECTRICAL
Sheet Number